

PC designs

Architecture & Construction

ARCHITECTURE | CONSTRUCTION | INTERIOR | MANAGEMENT | BIM | DIGITAL
www.pcdesigns.in | 7845223384



PC designs
Architecture & Construction

01 NATRAJ PAINTS

CLIENT - Mr NATRAJ
TYPOLOGY - COMMERCIAL
LOCATION - TIRUCHENGODE
SCOPE - FAÇADE
AREA - 2500 Sqft





PC designs
Architecture & Construction





COMMERCIAL



FACADE DESIGN

ARCHITECTURE | CONSTRUCTION | INTERIOR | MANAGEMENT | BIM | DIGITAL
www.pcdesigns.in | 7845223384


02 WARE HOUSE – STEEL STRUCTURE

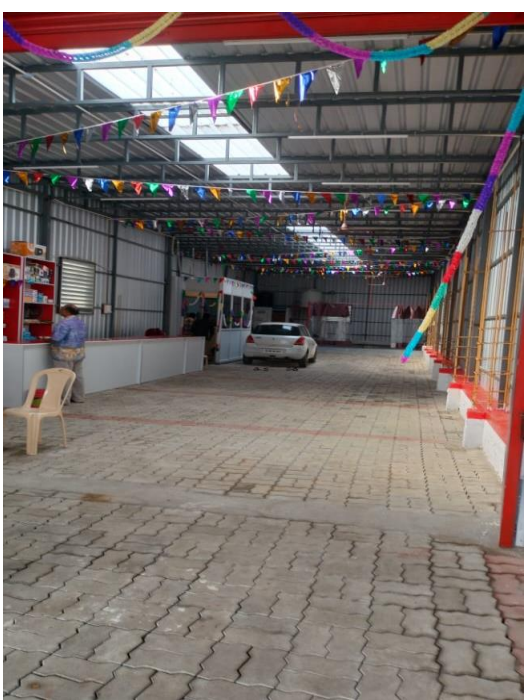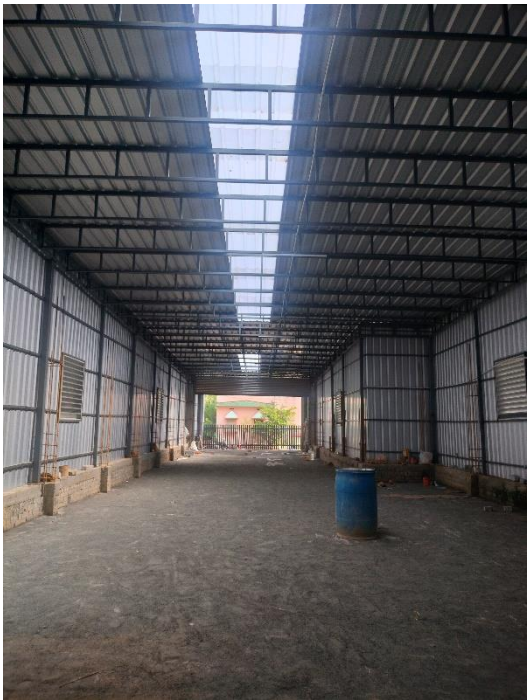

3000 SQFT – CAR CARE | FABRICATION



PC designs
Architecture & Construction

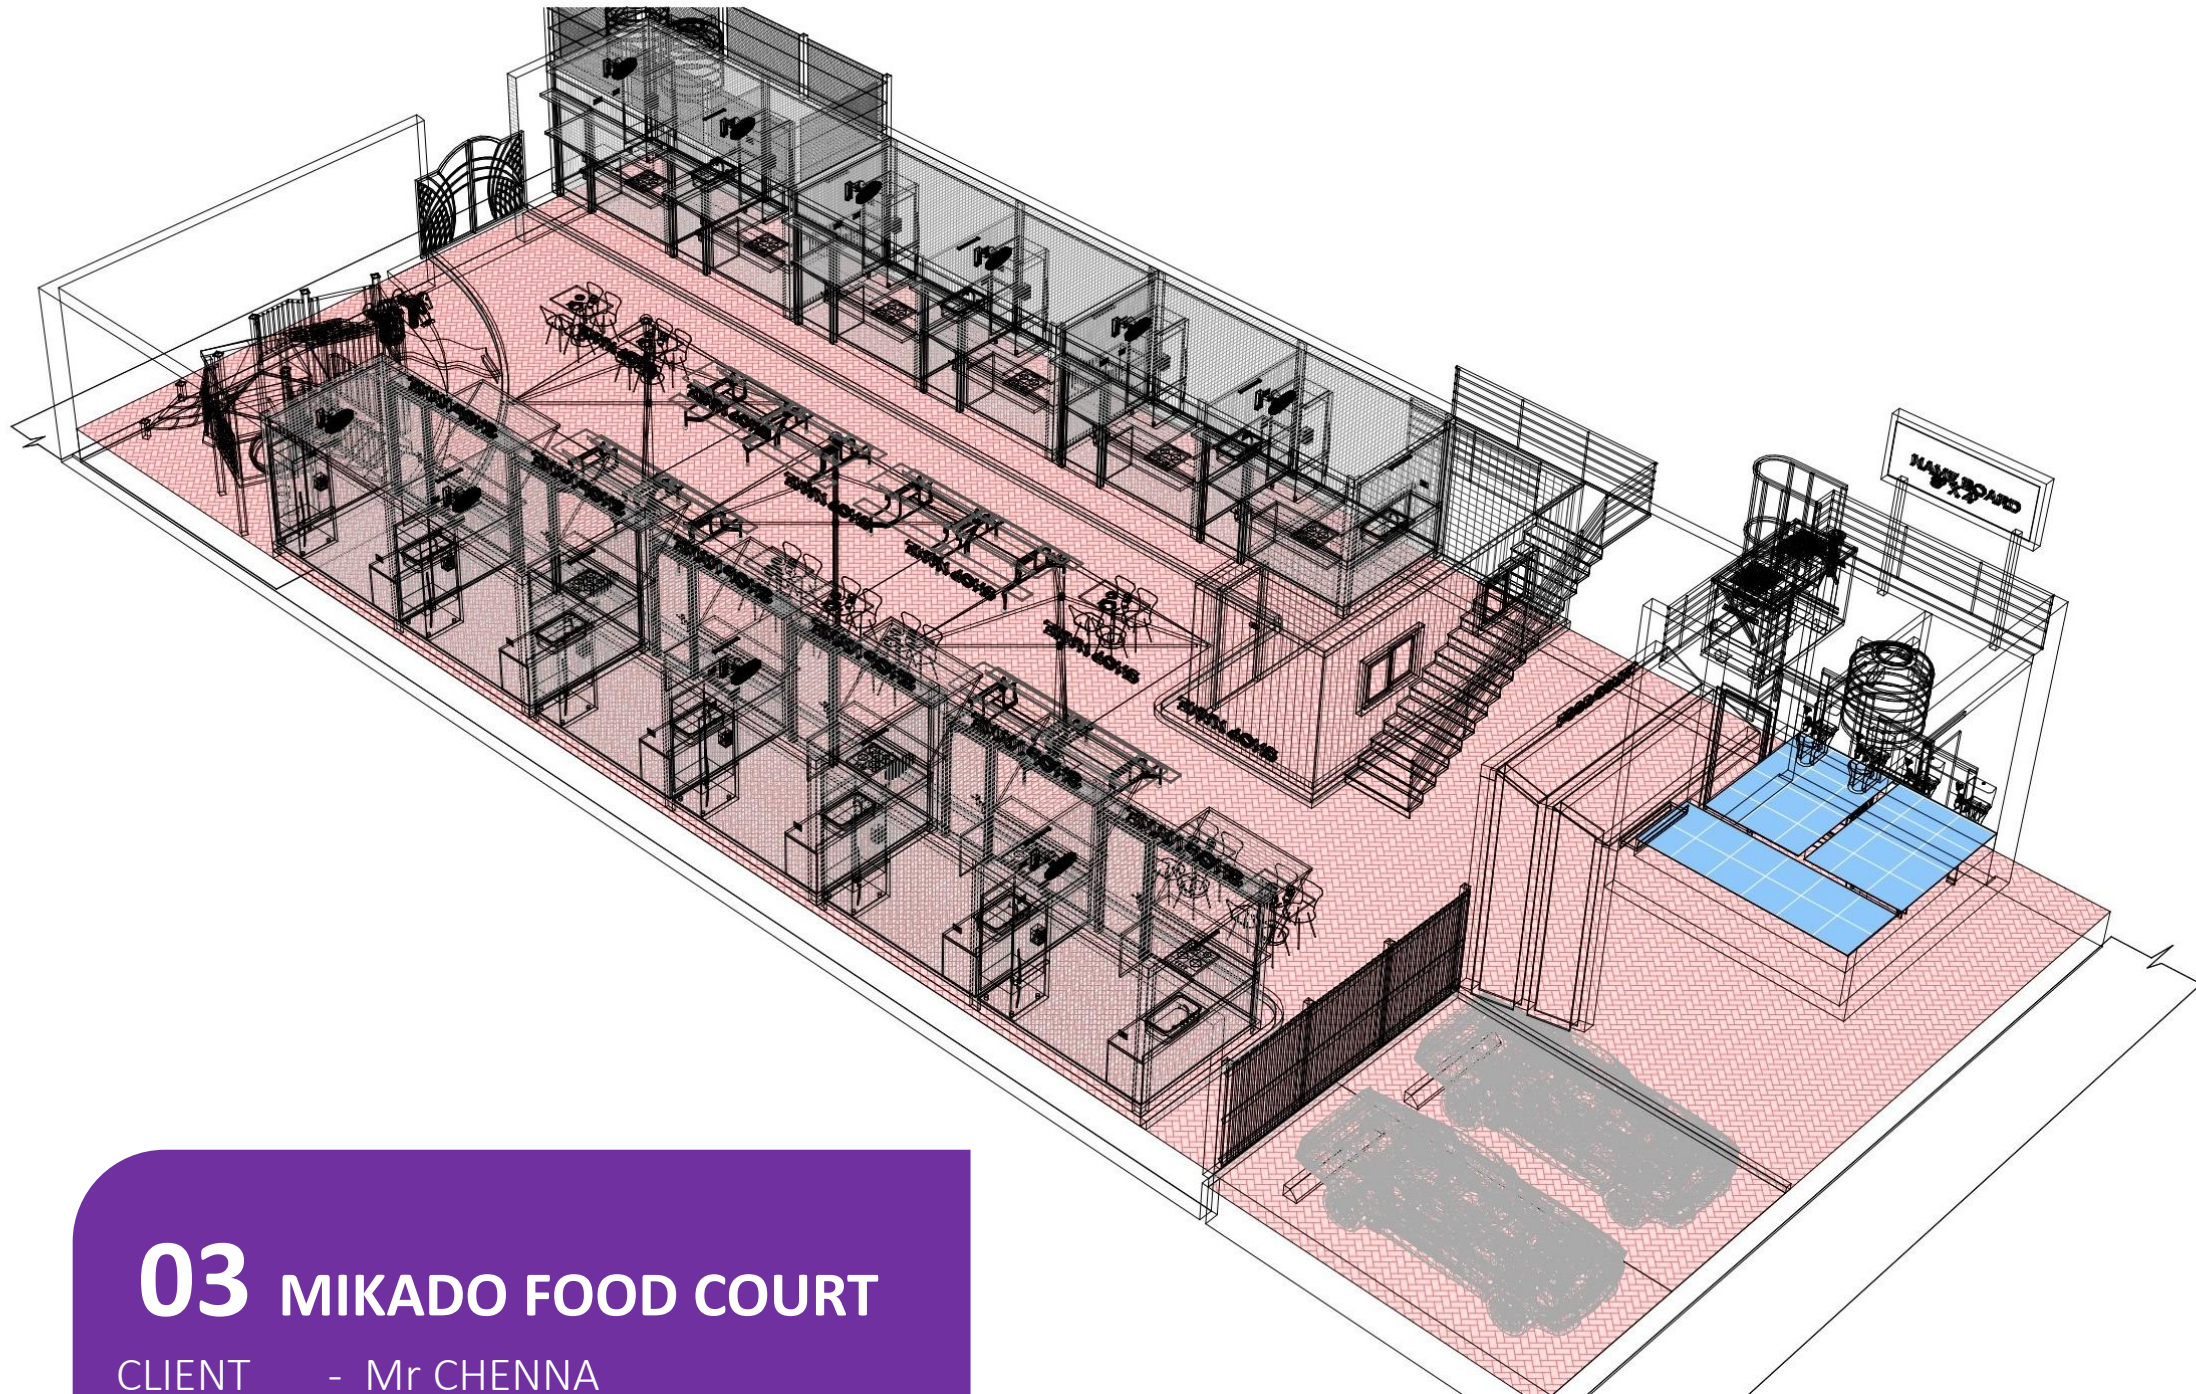


03 MIKADO FOOD COURT

CLIENT - Mr CHENNA
TYPOLOGY - COMMERCIAL
LOCATION - COIMBATORE
SCOPE - DESIGN
AREA - 4350 Sqft

ARCHITECTURE | CONSTRUCTION | INTERIOR | MANAGEMENT | BIM | DIGITAL

www.pcdesigns.in | 7845223384

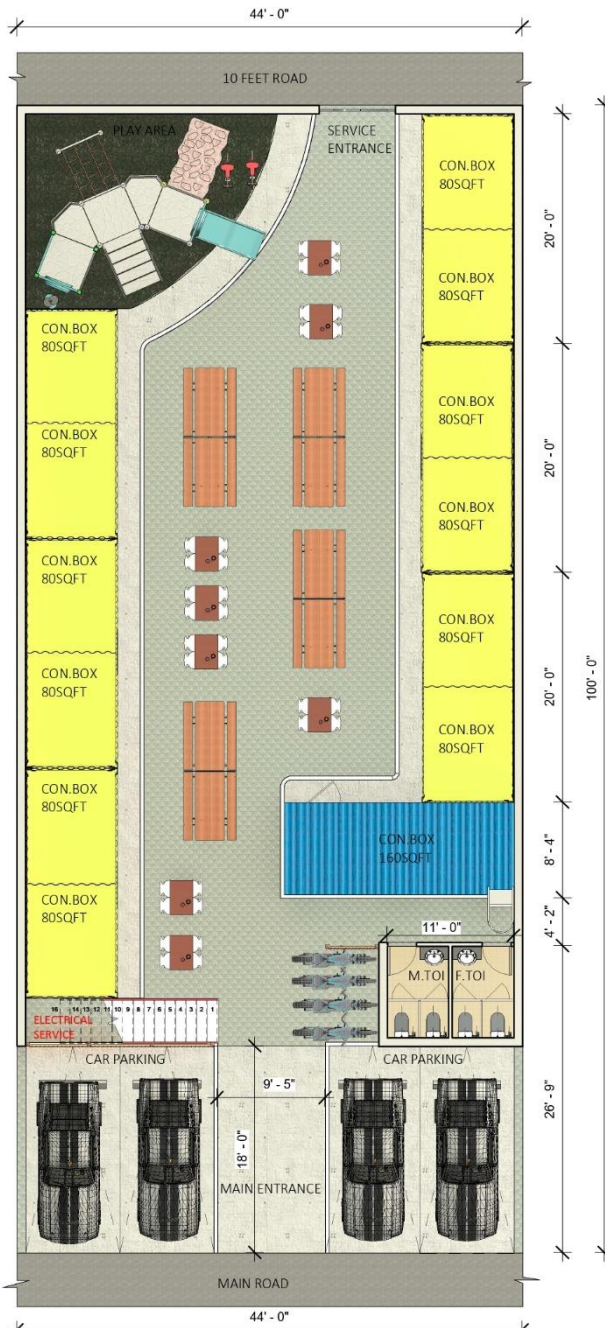

TYP. SEAT	FLOOR	COUNT	SEATS
4 SEATERS	ROOF TOP	7	28
16 SEATERS	GROUND	4	64
4 SEATERS	GROUND	8	32
TOTAL NO OF SEATS			124

CON. TYP	COUNT	AREA SQFT
80SQFT	12	960
160SQFT	03	480
TOTAL	15	1440

Sheet Title : GROUND FLOOR LAYOUT



Project Number : 033
Date : 24/09/2022
Scale : As indicated

Sheet No : A101
Detailed by : PC
Approved by : PC


Revision no : 1

Revision Date : 11/09/2022

PC designs
Copyright



Architects & Builders
Bangalore | Chennai | Madurai
Mob: 7845223384
www.pcdesign.in

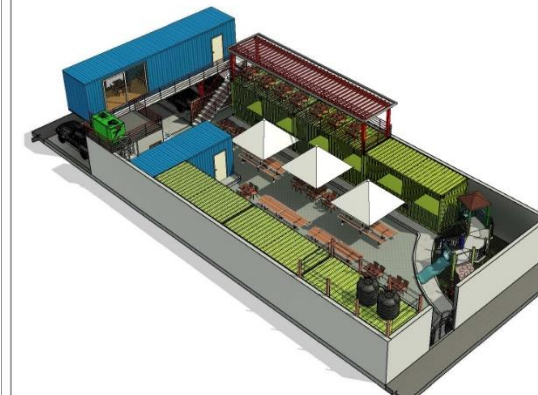

TYP. SEAT	FLOOR	COUNT	SEATS
4 SEATERS	ROOF TOP	7	28
16 SEATERS	GROUND	4	64
4 SEATERS	GROUND	8	32
TOTAL NO OF SEATS			124

CON. TYP	COUNT	AREA SQFT
80SQFT	12	960
160SQFT	02	320
TOTAL	14	1280

Sheet Title : FIRST FLOOR LAYOUT



Project Number : 033
Date : 24/09/2022
Scale : As indicated

Sheet No : A102
Detailed by : PC
Approved by : PC

Revision no : 1

Revision Date : 11/09/2022


PC designs
Copyright








Architects & Builders
Bangalore | Chennai | Madurai
Mob: 7845223384
www.pcdesign.in



PC designs
hitecture & Construction

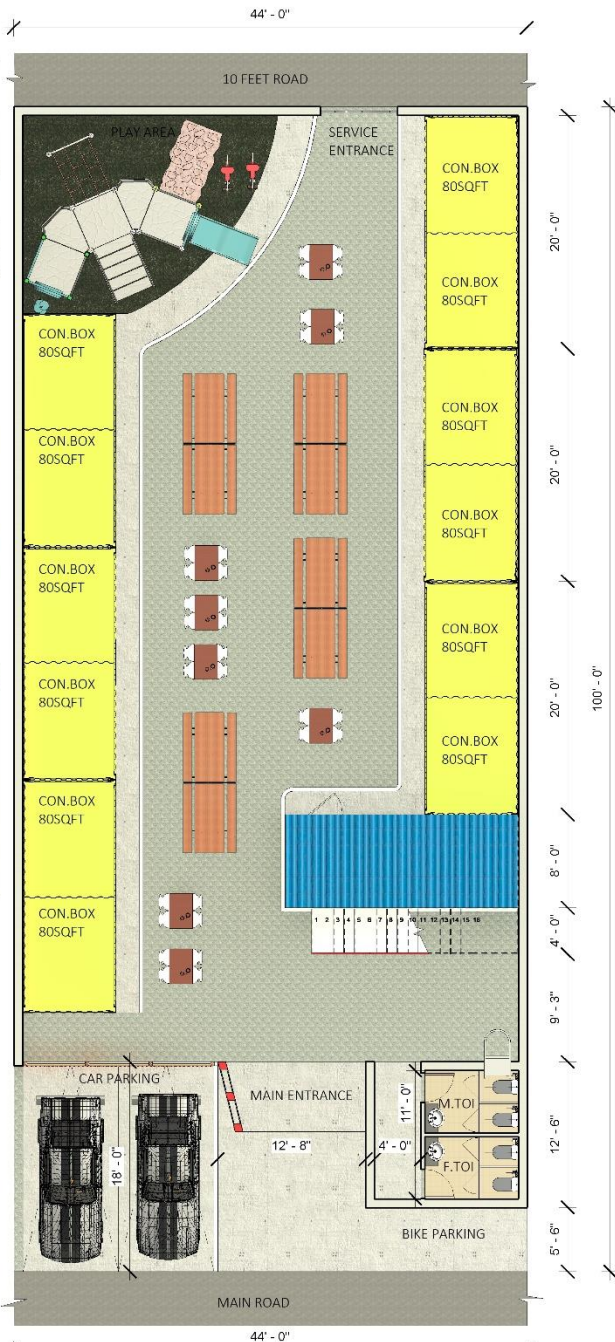

TYP. SEAT	FLOOR	COUNT	SEATS	CON. TYP	COUNT	AREA SQFT
16 SEATERS	GROUND	4	64	80SQFT	12	960
4 SEATERS	GROUND	8	32	160SQFT	01	160
TOTAL NO OF SEATS			96	TOTAL		1120

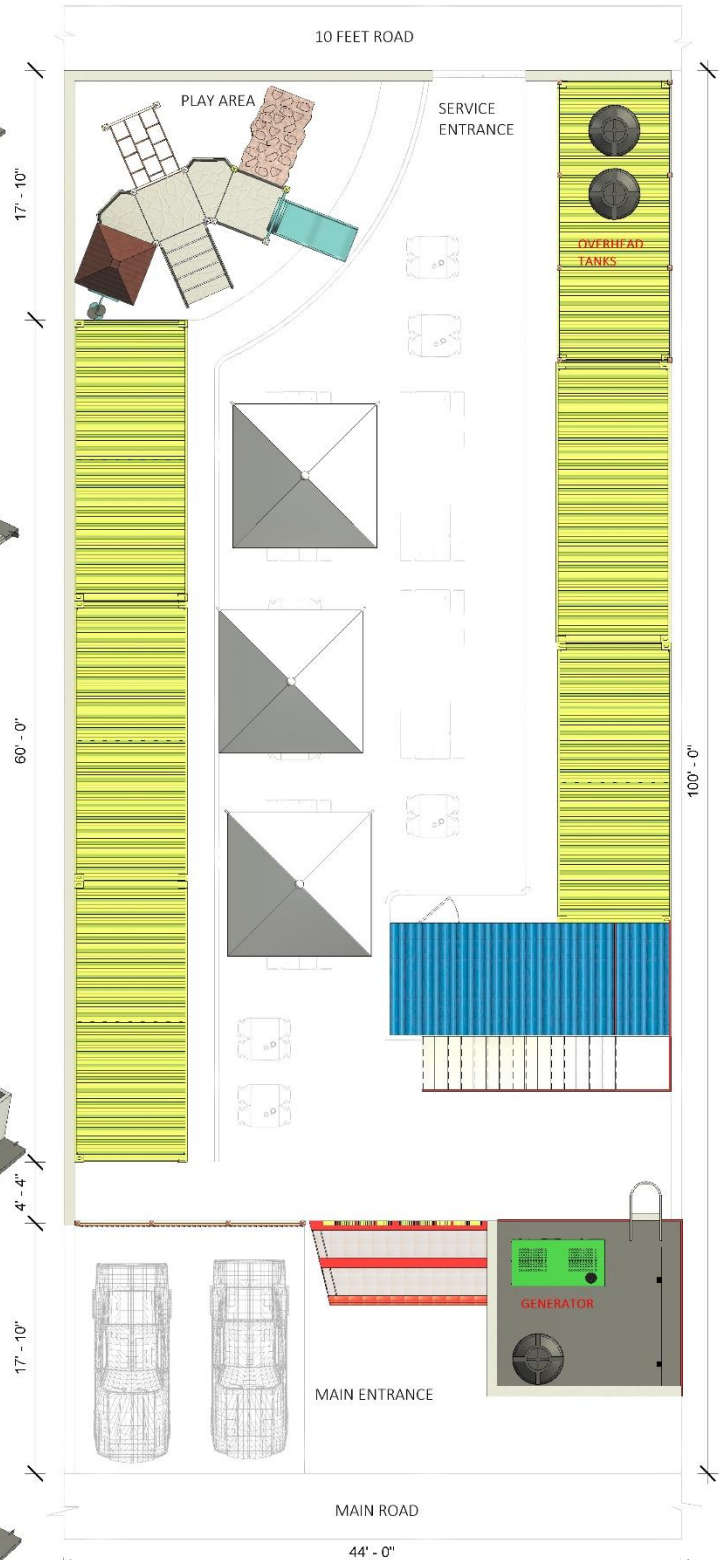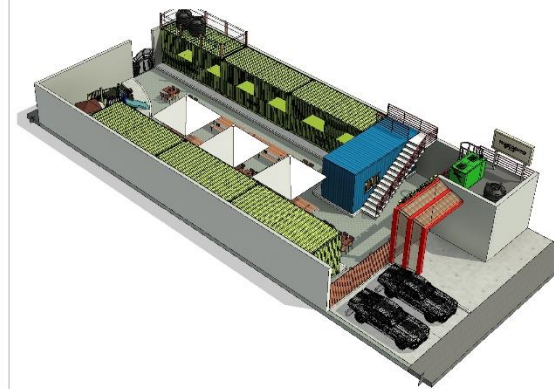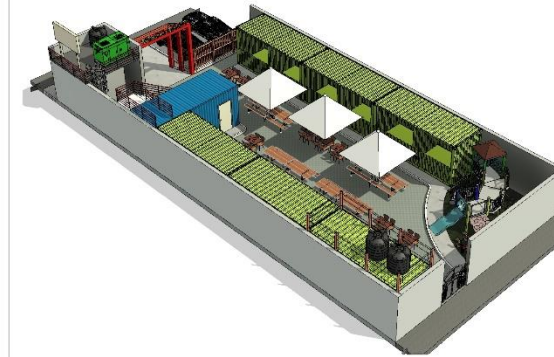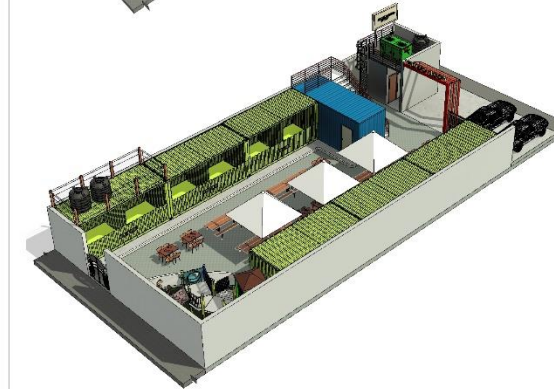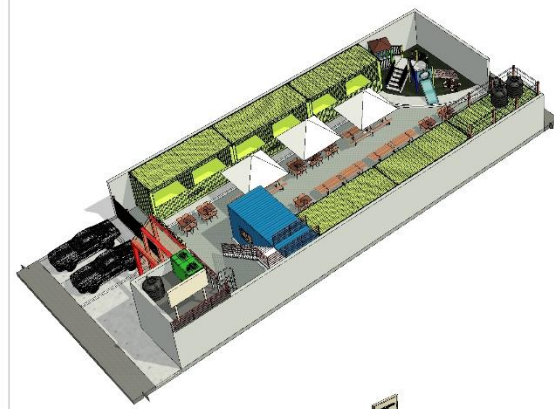

TYP. SEAT	FLOOR	COUNT	SEATS
16 SEATERS	GROUND	4	64
4 SEATERS	GROUND	8	32
TOTAL NO OF SEATS			96

CON. TYP	COUNT	AREA SQFT
80SQFT	12	960
160SQFT	01	160
TOTAL		1120

Sheet Title : GROUND FLOOR LAYOUT



Project Number : 033
Date : 22/10/2022
Scale : As indicated

Sheet No : A101
Detailed by : PC
Approved by : PC

Revision no : 2
Revision Date : 24/09/2022

PC designs
Copyright

Architects & Builders
Bangalore | Chennai | Madurai
Mob: 7845223384
www.pcdesigns.in

Sheet Title : FIRST FLOOR LAYOUT



Project Number : 033
Date : 22/10/2022
Scale : As indicated

Sheet No : A102
Detailed by : PC
Approved by : PC

Revision no : 2
Revision Date : 24/09/2022

PC designs
Copyright


Architects & Builders
Bangalore | Chennai | Madurai
Mob: 7845223384
www.pcdesigns.in

GENERAL LEGENDS


W01	Corrugated GI Sheet with internal MDF boards panelling
S01	M.S Door with hold draft & handles (26" x 7")
S02	M.S top hung door with folding channel (6' x 3/8")
GT	16mm granite top with 4" skirting on wall
CF	18mm Cement sheet with carpet
RF	Refrigerator
S.C.L	Structural concrete level

ELECTRICAL LEGENDS


	SWITCH - SINGLE WAY
	TUBELIGHT
	5 AMP SOCKET
	15 AMP SOCKET

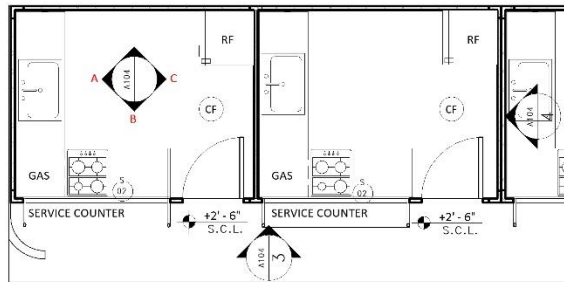


1. PROTOTYPE PLAN
1 : 50

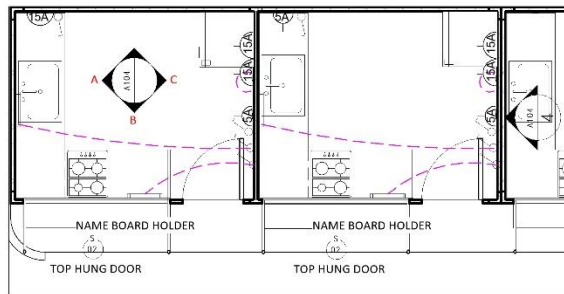


2. ELECTRICAL PLAN
1 : 50

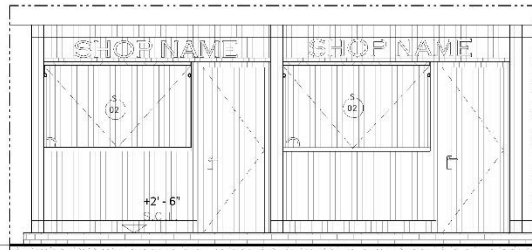


3. FRONT ELEVATION
1 : 50

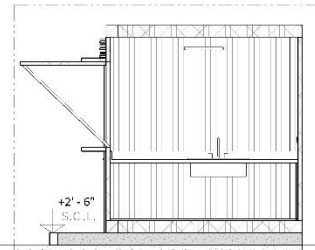


4. SIDE ELEVATION
1 : 50

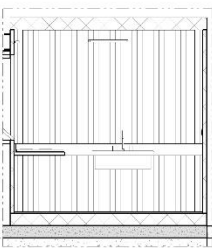

5. WALL ELEVATION A
1 : 50

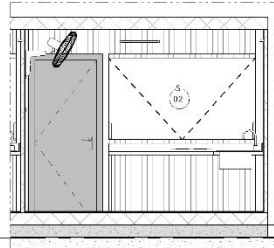


6. WALL ELEVATION B
1 : 50

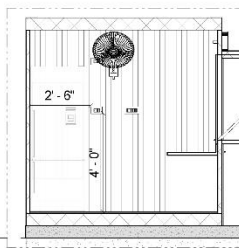

7. WALL ELEVATION C
1 : 50



1. FRONT VIEW

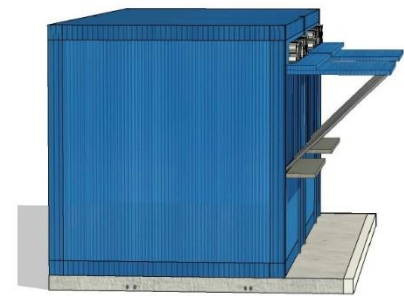


4. SIDE VIEW



2. ISOMERTRIC VIEW 01



5. INTERIOR VIEW -01

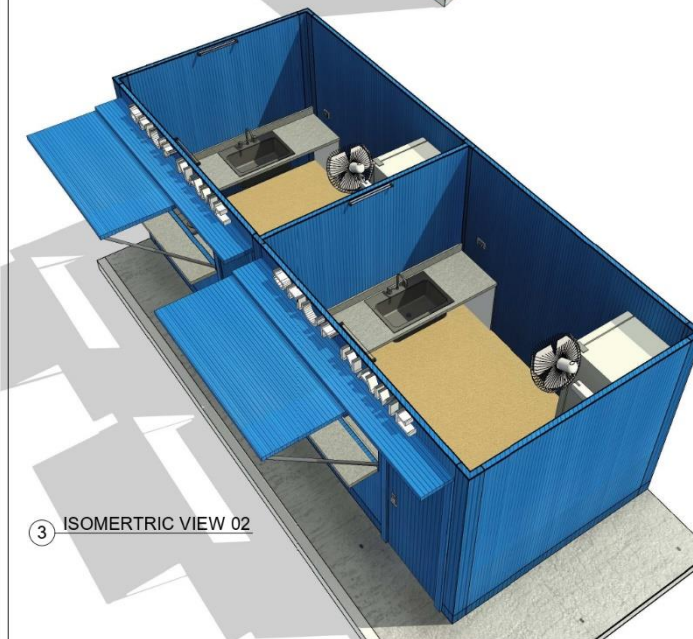

3. ISOMERTRIC VIEW 02



6. INTERIOR VIEW -02

Sheet Title : SHOP DETAILING -01

Client Name : Proposed the food street @
coimbatore



Project Number : 033

Date : 23-11-2022

Scale : As indicated

Sheet No : A104

Detailed by : RK

Approved by : PC

Revision no :

Revision Date :

PC designs



Architects & Builders
Bangalore | Chennai | Madurai
Mob: 7845223384
www.pcdesign.in

Sheet Title : SHOP DETAILING -02

Client Name : Proposed the food street @
coimbatore



Project Number : 033

Date : 12-11-2022

Scale :

Sheet No : A105

Detailed by : RK

Approved by : PC

Revision no :

Revision Date :

PC designs



Architects & Builders
Bangalore | Chennai | Madurai
Mob: 7845223384
www.pcdesign.in



Sheet Title : **CONCEPTUAL DESIGN**
Client Name : **Proposed the food street @ coimbatore**



Project Number : 033
Date : 23-11-2022
Scale :
Sheet No : A103
Detailed by : PC
Approved by : PC
Revision no :
Revision Date :

PC designs
Architects & Builders
Bangalore | Chennai | Madurai
Mob: 7845223384
www.pcdesign.in
Copyright



PC designs
Architecture & Construction



CONTAINER

OFFICE & CAFE





PC designs
Architecture & Construction



04 BIM APARTMENT

